
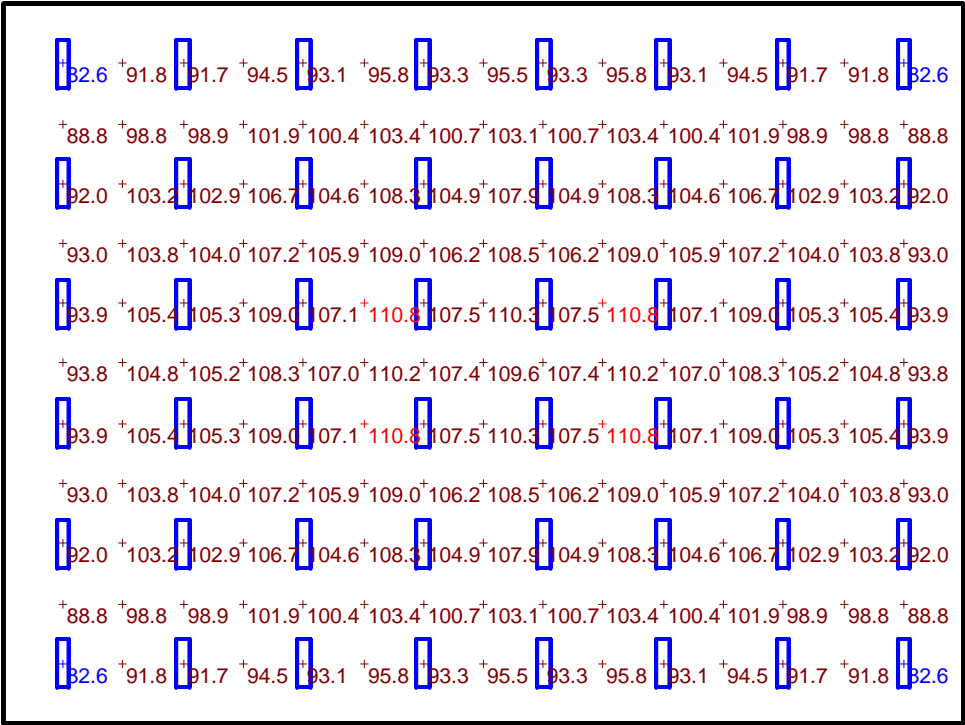



STATISTICS	
Description	Symbol
Workplane	+

LUMINAIRE SCHEDULE									
Symbol	Label	Qty	Catalog Number	Description	Lamp	File	Lumens	LLF	Watts
	LM-1	48	TSN454EB1-8 STANDARD REFLECTOR	FORMED STEEL HOUSING WITH 30, 1" X 1/16" SLOTS, FORMED SPECULAR ALUMINUM REFLECTOR, NO ENCLOSURE.	FOUR 54 WATT HIGH OUTPUT T5 LINEAR FLUORESCENT LAMPS RATED AT 4400 LUMENS EACH.	TBN454EB.ies	4400	0.49	223



Plan View
 Scale 1" = 16'



Designer

Date
 Aug 30 2010

Scale

Drawing No.

1 of 1